



Zone	Rev	Description	Revised By	Date	Approval
ALL	A	FIRST ISSUE	MFR	07/08/19	
ALL	B	REVISED PROTEL ROUTER PANELS	MFR	16/09/19	


LINE SELECT CONTROL (NOT IMPLEMENTED)

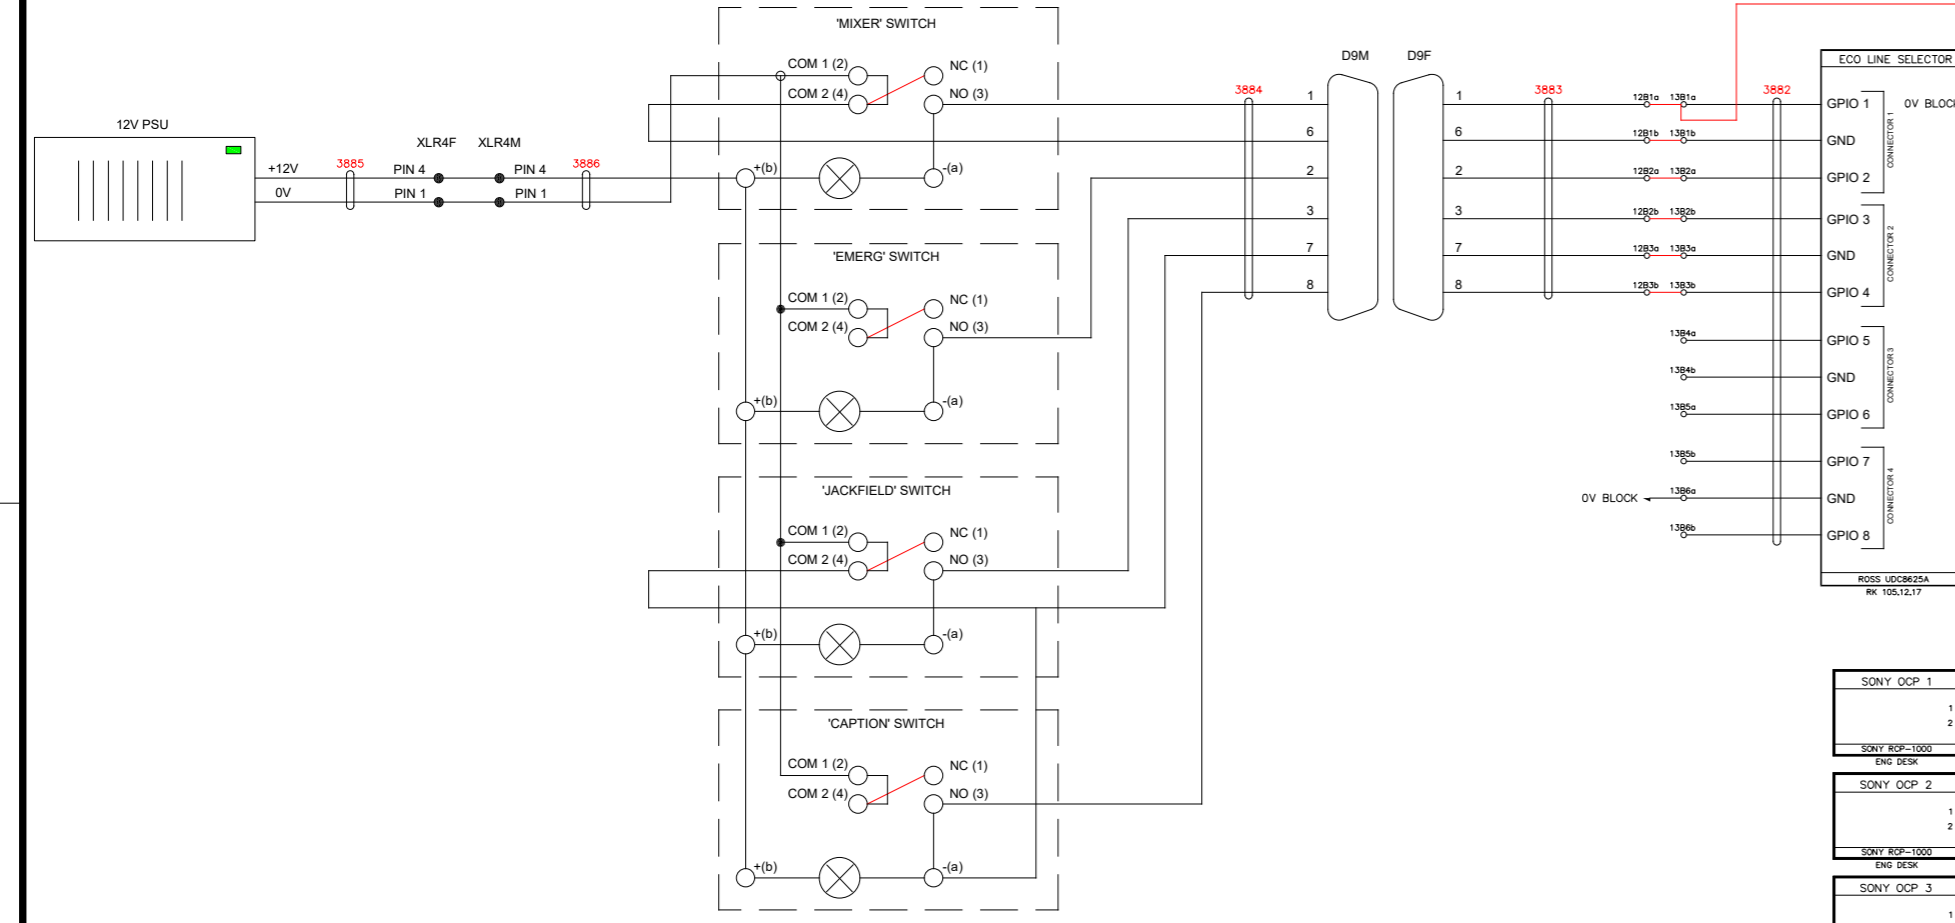


RED LIGHT SWITCHING

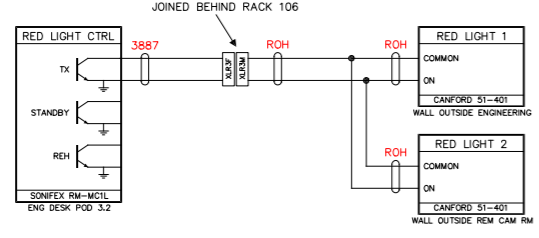


CAMERA TALKBACK CONTROL

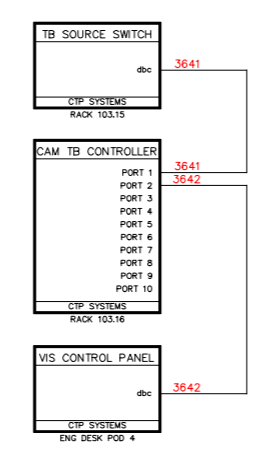





UMD CONTROL

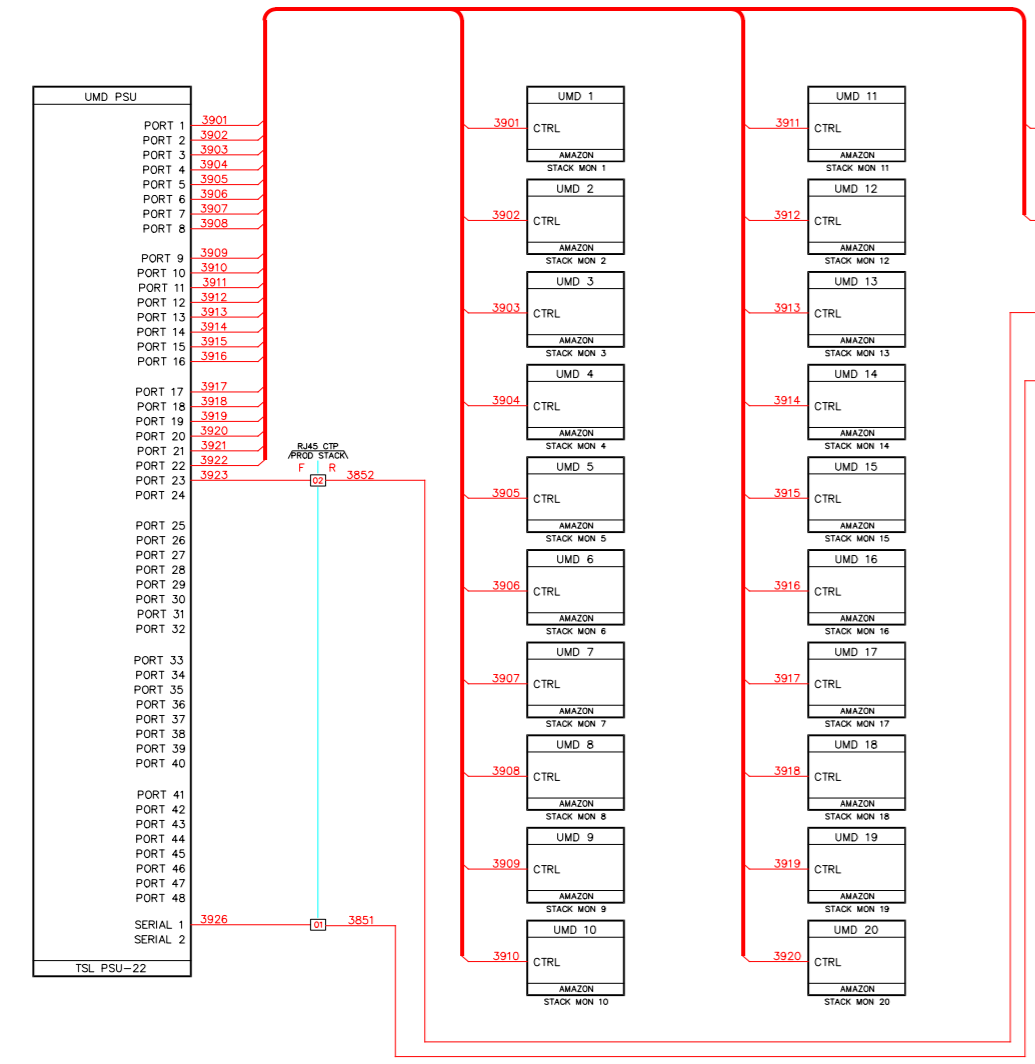

ROUTER PANEL CONTROL (SERIAL CABLES INSTALLED BUT NOT USED)

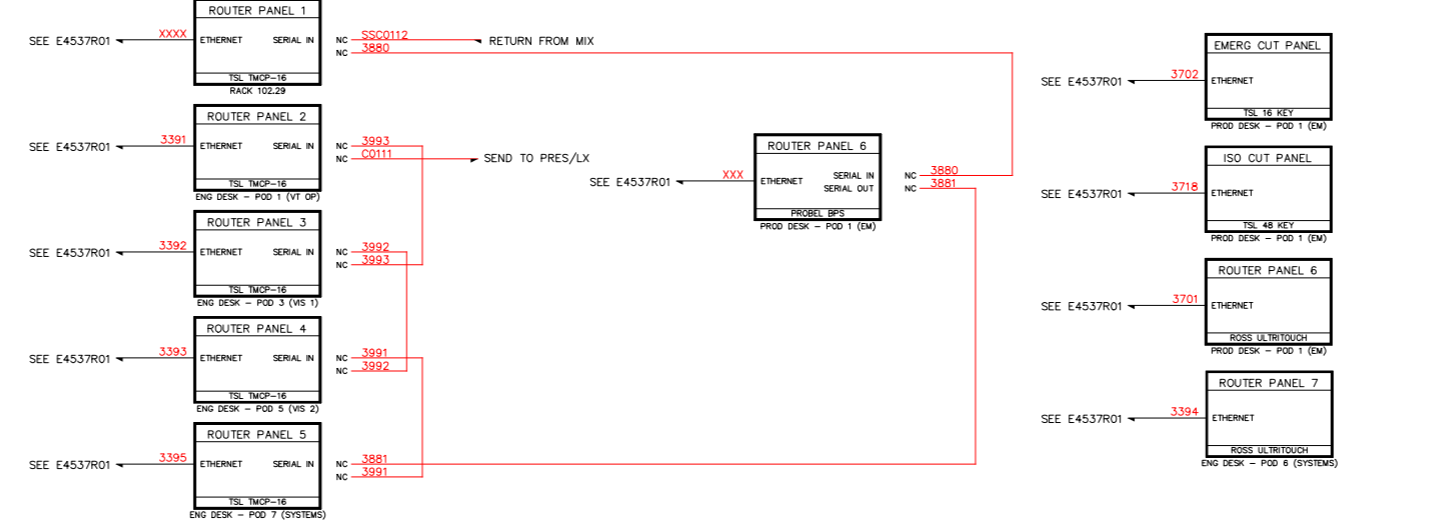

LOUDSPEAKER LEVEL CONTROL

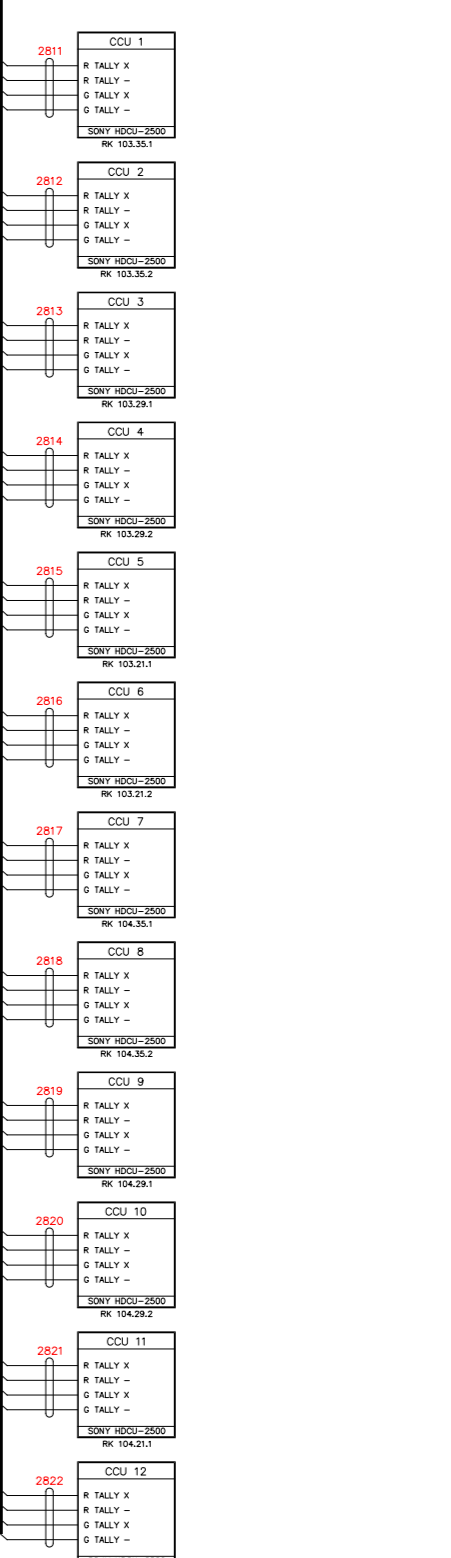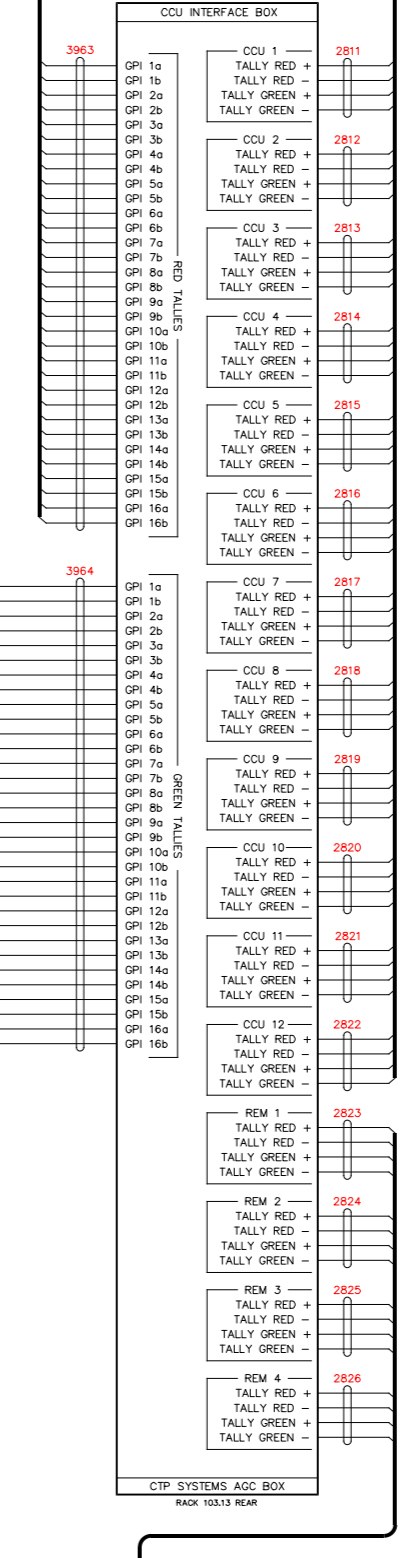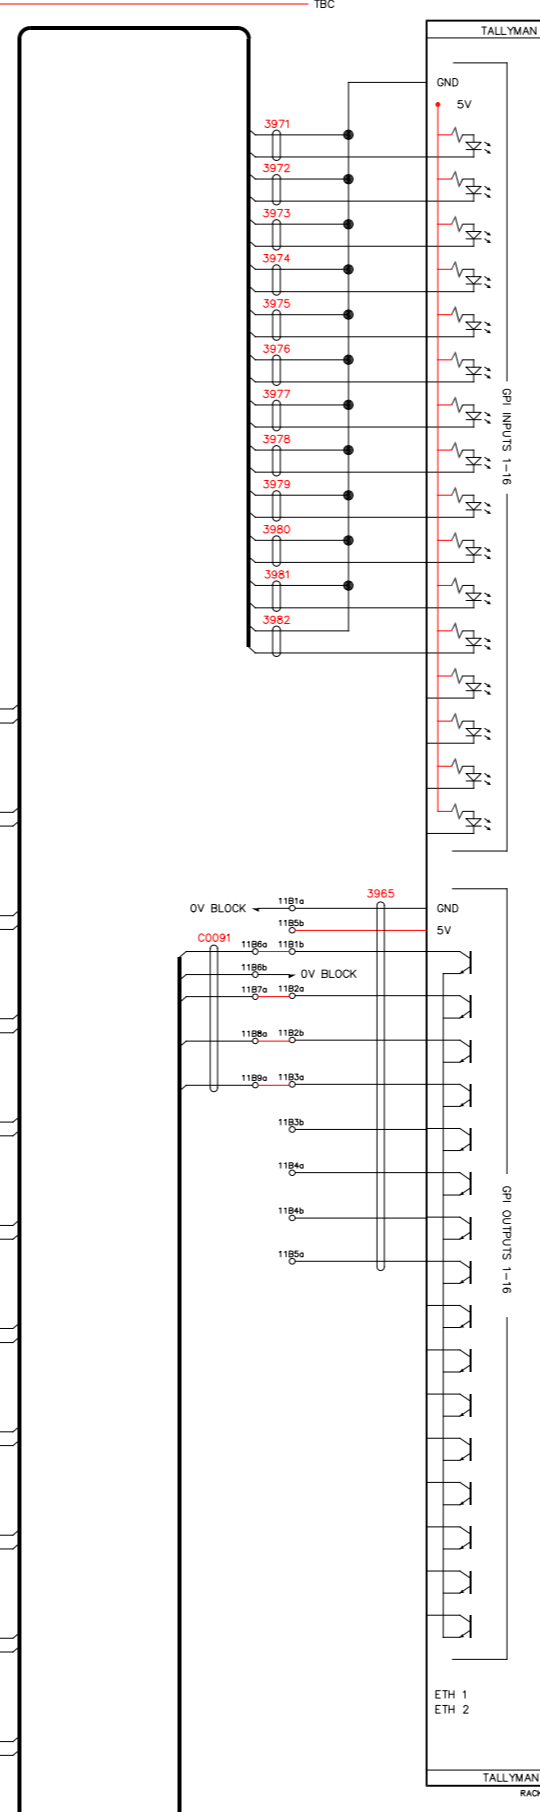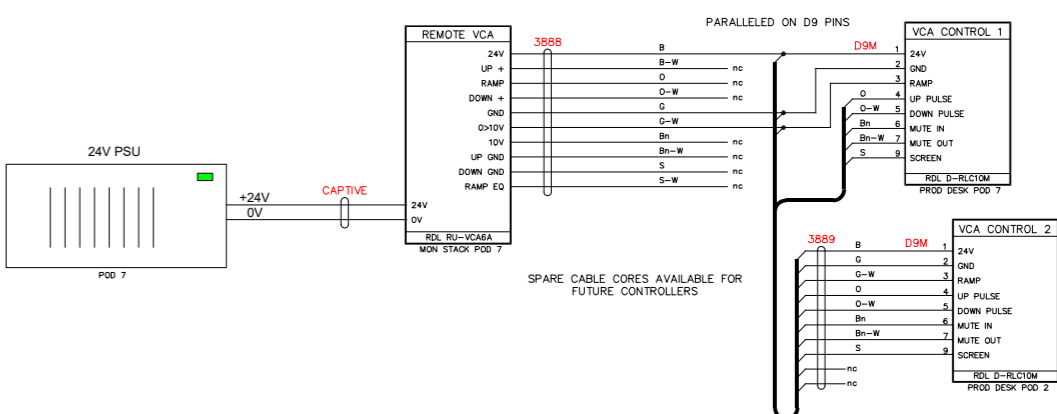

MHz

UNIT 39 LANCASTER WAY
WITCH BROD, ELY
CAMBRIDGESHIRE
CB6 3NW
UNITED KINGDOM
(TEL) +44 (0)1353 645000
(FAX) +44 (0)1353 658919
www.megahertz.co.uk

© 2019 MEGHERTZ LIMITED
The contents of this document are confidential and are not to be disclosed to a third party without the prior written permission of MEGHERTZ LTD

Project Address

ROYAL OPERA HOUSE
GOVET PARK

Proj. Mgr.: KN
Designer: MFR
Approved: MFR
Drawn: MFR
Scale: N.T.S.
File Ref.: (REVISED FOR NEW 100 SERIES SWITCHES & RACK) No. of sheets: 1 of 1

Proj. Start Date: 22/05/19
Last Plot: 16/09/19
Issue Date: 16/09/19
MFR

ROYAL OPERA HOUSE
ROH
MEDIA SUITE
CONTROL SCHEMATIC

Rev No. 4537 Rev No. E4537R02 Rev No. B